

RECEIVED

JAN 8 2021

CITY OF MACEDONIA
BUILDING DEPARTMENT

PREVIOUS SET ISSUE:	DATE:
PLANNING / APR:	12.21.2020
ITA MEETING:	01.20.2021
CURRENT SET:	
PERMIT / CONSTRUCTION SET:	
ISSUE DATE:	01.29.2021

REVISIONS		
NO.	DESCRIPTION	DATE



SOUTHEAST AERIAL VIEW
OH-8

EXISTING LOCATION OF
GATEWAY SIGNAGE

LOCATION OF NEW
MONUMENTAL SIGN



SOUTHEAST PERSPECTIVE VIEW
OH-8

LOCATION OF NEW
MONUMENTAL SIGN



NORTH AERIAL VIEW
INTERSECTION OF OH-8 AND E AURORA RD

LOCATION OF NEW
MONUMENTAL SIGN

EXISTING LOCATION OF
GATEWAY SIGNAGE



NORTH PERSPECTIVE VIEW
OH-8

LOCATION OF NEW
MONUMENTAL SIGN



THE SPANISHES THE PROPERTY OF MELD ARCHITECTS, INC. ALL RIGHTS RESERVED. THIS DOCUMENT, AS WELL AS THE CONTENTS THEREOF, ARE THE PROPERTY OF MELD ARCHITECTS, INC. THE USE FOR PURPOSES OTHER THAN THE EXPRESSLY STATED HEREON IS STRICTLY PROHIBITED WITHOUT EXPRESS WRITTEN CONSENT OF MELD ARCHITECTS, INC.
© 2020 Meld Architects, Inc.



Golden Link Blvd. Signage
City of Macedonia
Golden Link Blvd and State Route 8
Northfield, OH 44057
Meld project number: 20007

Sheet Name:
PERSPECTIVES

Sheet Number:
A003

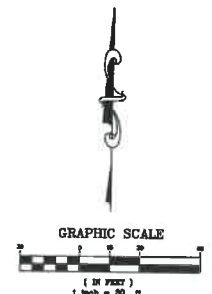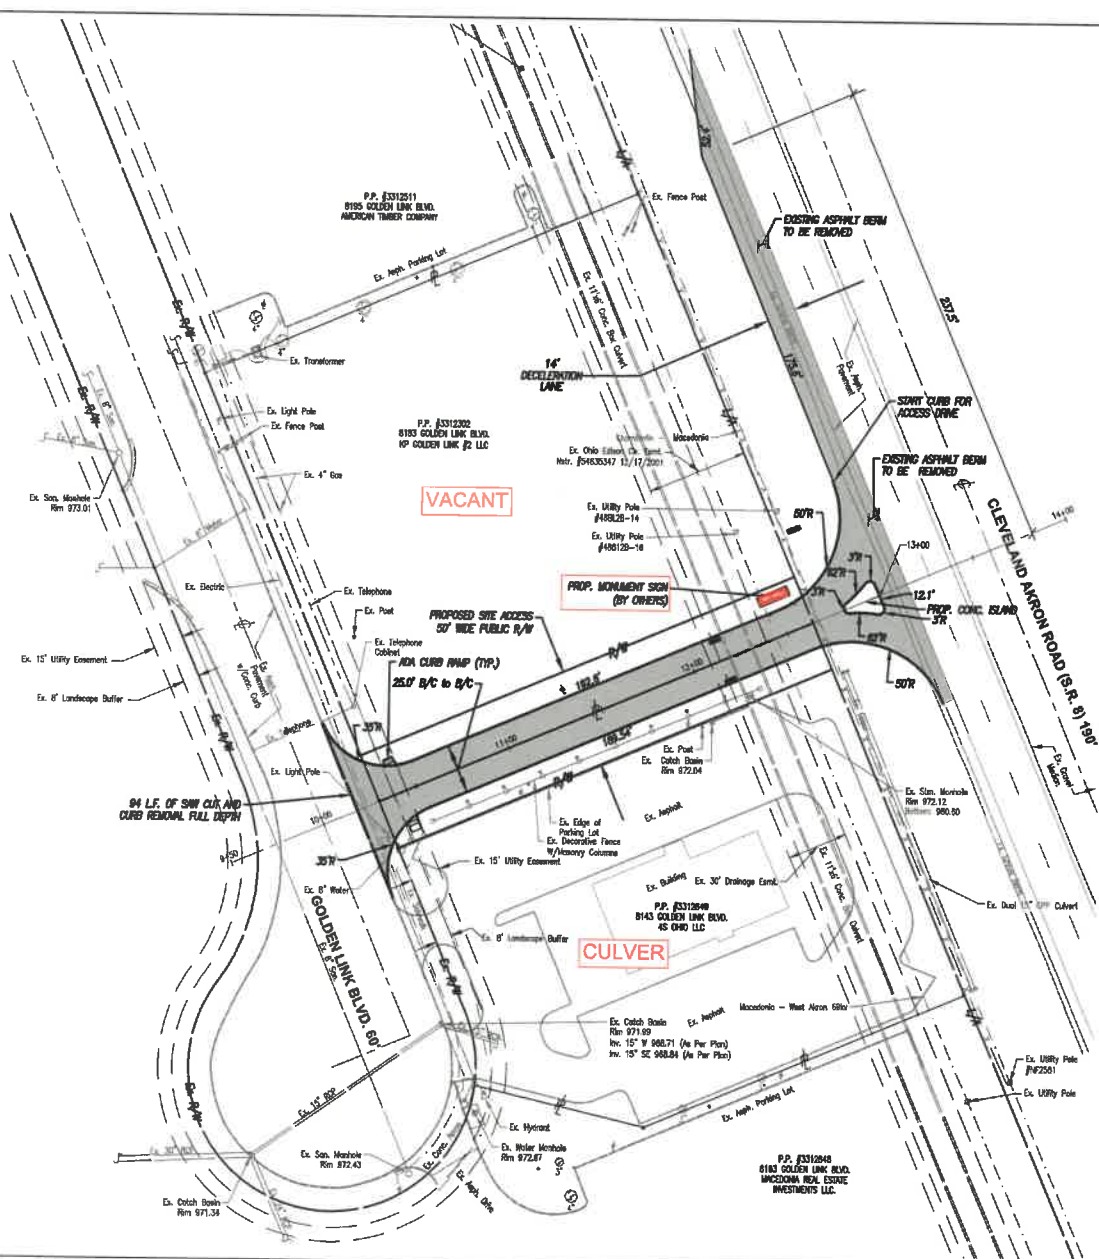

— PROPOSED ACCESS DRIVE

INDEX OF SYMBOLS

○ Utility Pole	○ Water Service Valve
⊕ Light Pole	○ Water Valve Box
— Dig Wire	○ Sewer Manhole
— Sign	⊕ Joint Basin
• Metal Post	— Hicrest
— Chain Link Fence	⊕ Electrical Box
⊕ Water Meter	⊕ Gas Valve
⊕ Fire Hydrant	— Ex. Storm Service
⊕ Gas Manhole	— Ex. Sanitary Service
⊕ Telephone Box	⊕ Telephone Manhole
— Tree or Bush Row	— PROP. HEADWALL

- NOTE
- 1.) ALL DIMENSIONS ARE TO FACE OF CURB
 - 2.) CONCRETE ISLAND SHALL HAVE ODOT TYPE 3 MOUNTABLE CURB
 - 3.) ODOT STD EP-0.1 SHALL BE A PART OF THESE DRAWINGS.

RECEIVED
JAN 8 2021
CITY OF MACEDONIA
BUILDING DEPARTMENT

CVE CHAGRIN VALLEY ENGINEERING, LTD.
Creative Engineers. Intelligent Solutions.
2098 Eastwood Road, Suite 100, New Paris, OH 43105
Phone: 440.331.1997 Fax: 440.331.1570
www.cve-engineers.com

SITE PLAN
GOLDEN LINK BLVD. ACCESS DRIVE
CITY OF MACEDONIA
COUNTY OF SUMMIT
STATE OF OHIO

DESIGNED BY:	PHZ
DRAWN BY:	ELM
CHECKED BY:	JLD
DATE:	APRIL 2020
SCALE:	1"=50'
PROJECT NUMBER:	16120
Drawing Name:	16120 - MASTER
SHEET:	3
TOTAL SHEETS:	14

Ohio Utilities Protection Service
Call 811
before you dig